


**MARIO I. LEBRILLA**  
 Professional Electrical Engineer  
 PRC # 3972 Validity: 10/12/2019  
 PTR # 1018215 Date Issued: 1/3/2019  
 Place Issued: Cabuyao, Laguna  
 TIN # 144-186-639

# ONE LINE DIAGRAM

APPROVED AS BUILT  
 PLOW  
 CITY HALL AND  
 METALCO

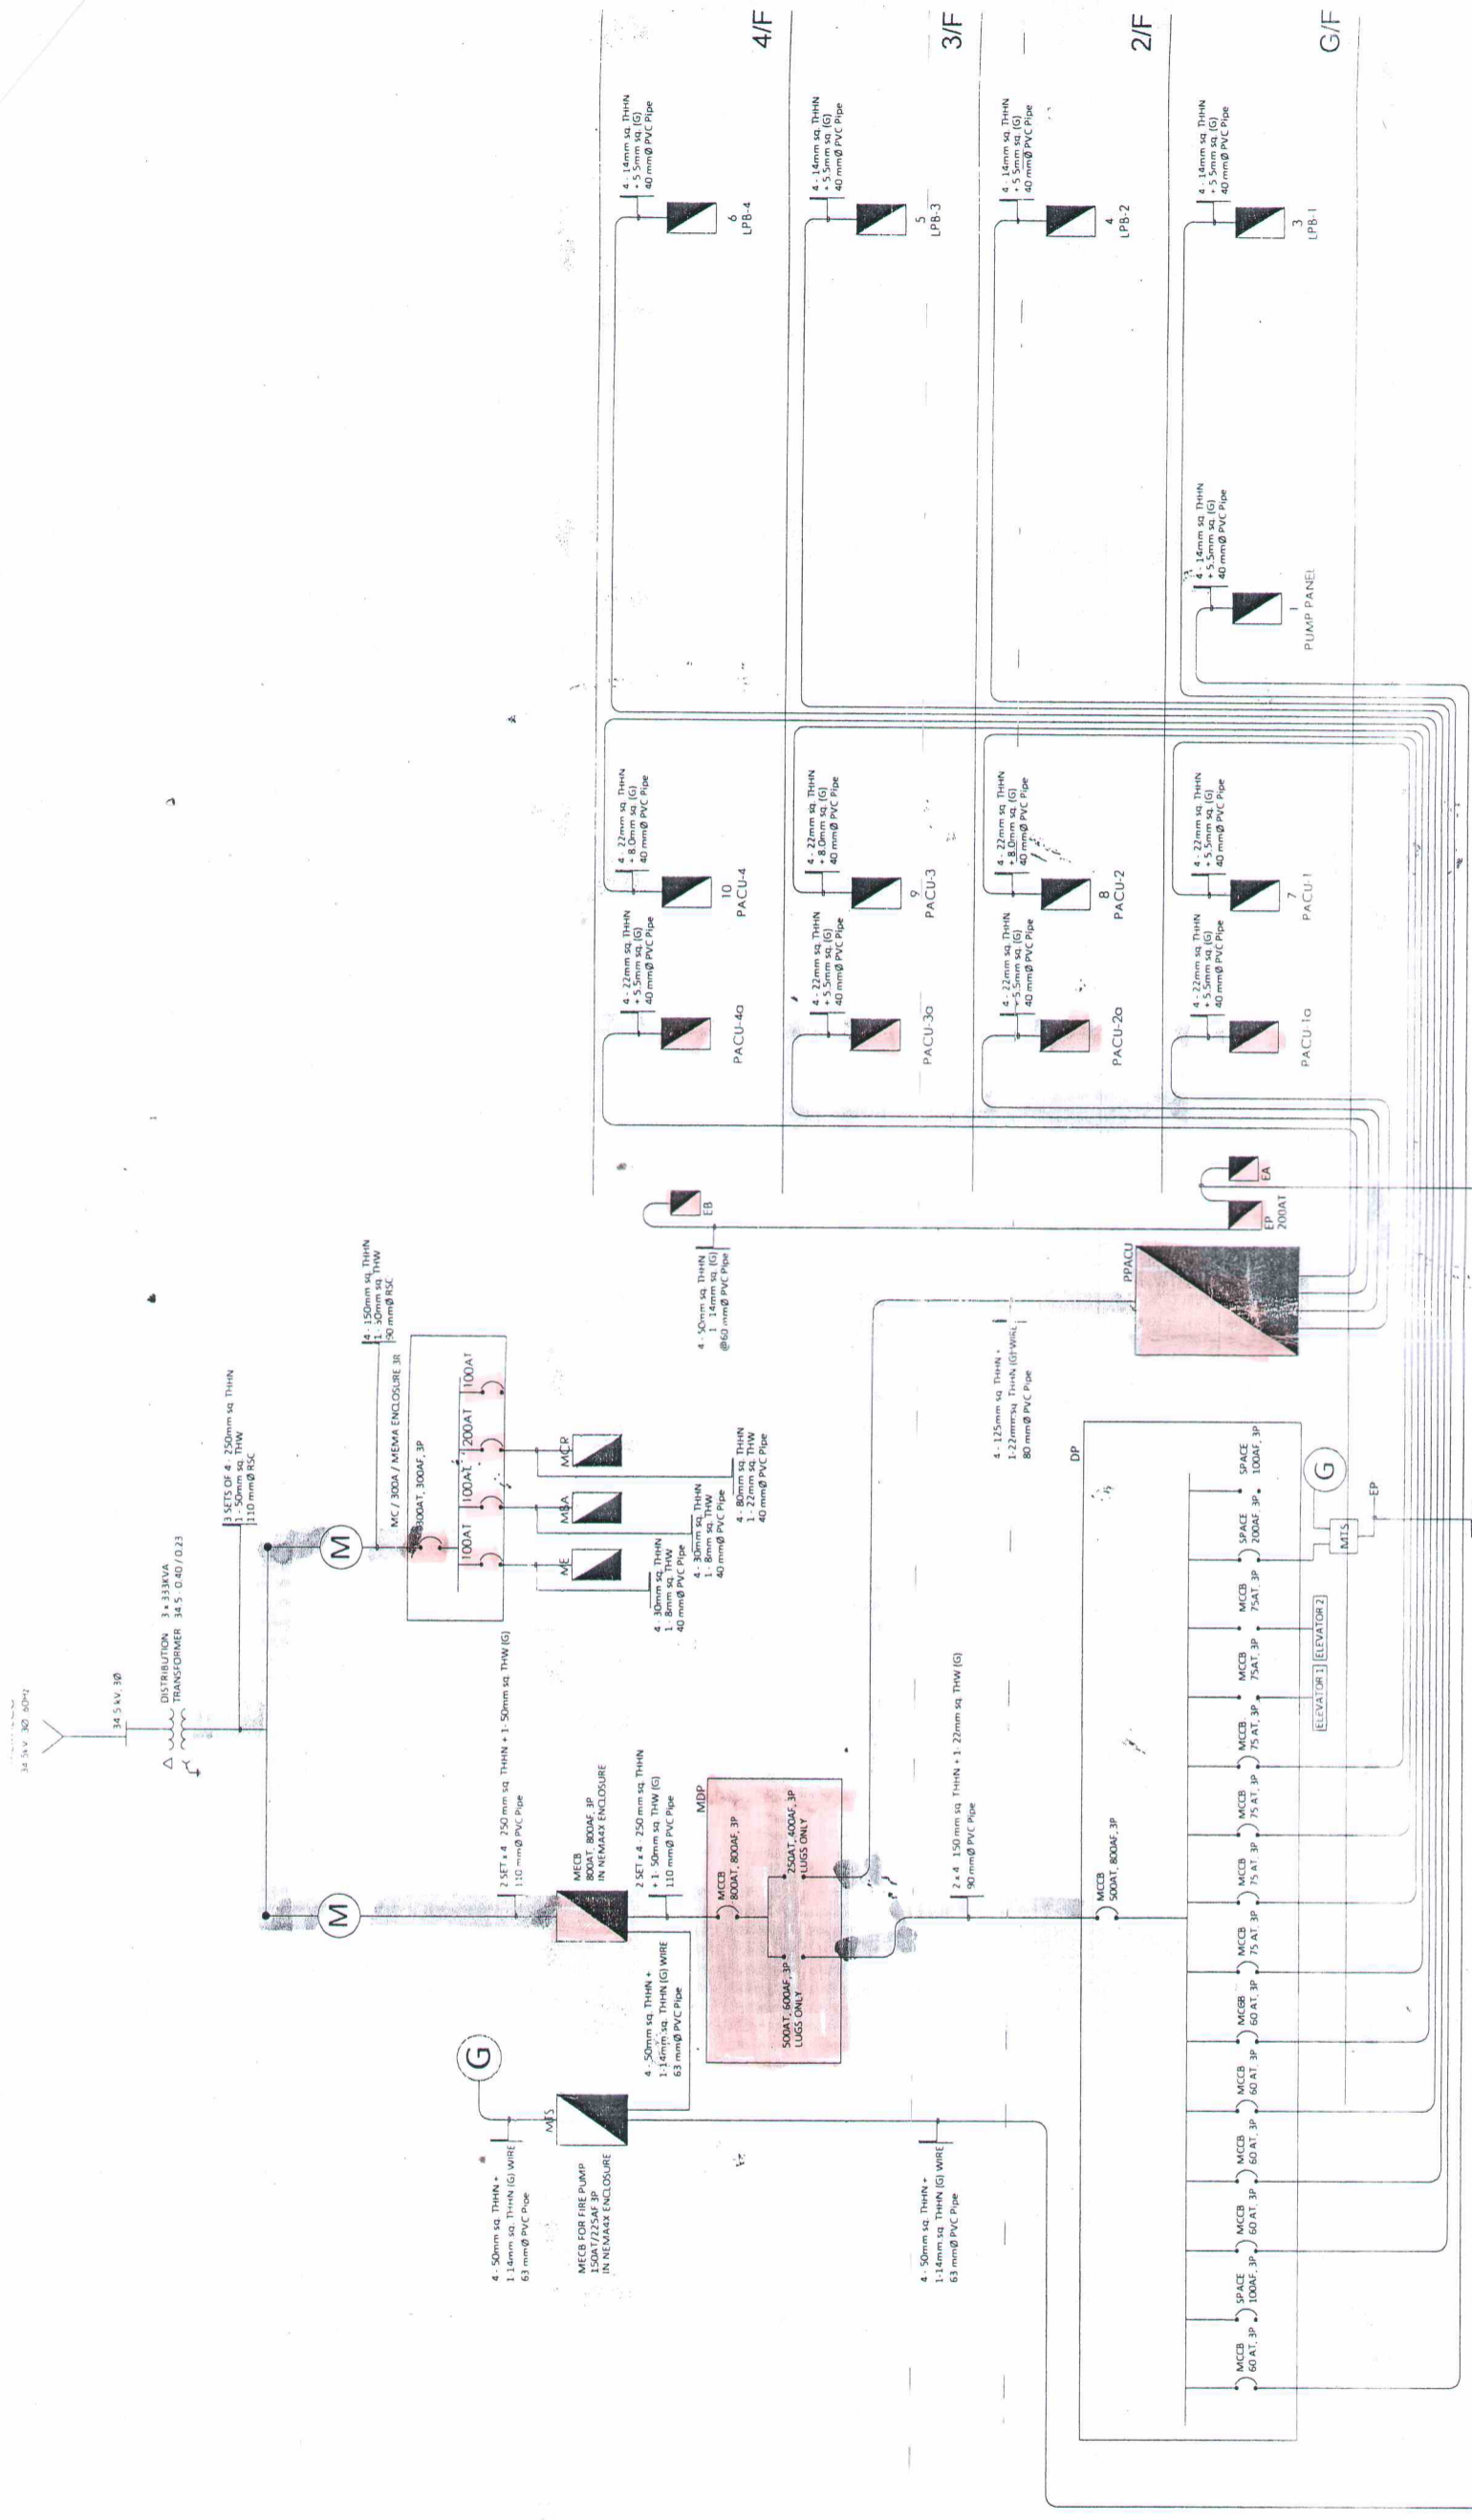

PRC NO	DATE	DESCRIPTION

PRC NO	DATE	DESCRIPTION

OWNER: PHILIPPINE PUBLIC SAFETY COLLEGE  
 PROJECT TITLE: REVISED PPSC FOUR - STOREY SCHOOL BUILDING WITH ROOF DECK  
 LOCATION: PPSC KATIPUNAN AVE. MWGS COMPOUND QUEZON CITY

RECOMMENDED BY: [Signature]  
 RECOMMENDING APPROVAL: [Signature]  
 SUBMITTED BY: [Signature]  
 APPROVED BY: [Signature]

SHEET NO	SHEET NAME	SHEET CONTENTS