



REPUBLIC OF THE PHILIPPINES
DEPARTMENT OF THE INTERIOR AND LOCAL GOVERNMENT

PHILIPPINE PUBLIC SAFETY COLLEGE

MWSS COMPOUND, CORNER AYALA HEIGHTS, BRGY. OLD BALARA, QUEZON CITY, METRO MANILA, NCR, PHILIPPINES

IMPROVEMENT OF CONFERENCE ROOM ACCENT WALL AT PPSC HEAD OFFICE BUILDING


ARCHITECTURAL DESIGN DRAWINGS

TABLE OF CONTENTS	
A-01	FRONT PAGE, TABLE OF CONTENTS
A-02	PERSPECTIVE CONFERENCE HALL FLOOR PLAN ELEVATION 01
A-03	PPSC LOGO PART DETAILS DILG LOGO PART DETAILS GROOVE DETAILS BLOW-UP PLAN 01 BLOW-UP PLAN 02 COVE LIGHTING DETAILS


<p>RA 8206 ART IV Sec. 13 Professional Architect</p> <p>Engr. MICHEL B. VERAY Civil Engineering Services</p>		<p>PROJECT OWNER</p> <p>PHILIPPINE PUBLIC SAFETY COLLEGE DEPARTMENT OF THE INTERIOR AND LOCAL GOVERNMENT ADDRESS: MWSS COMPOUND CORNER AYALA HEIGHTS, BRGY. OLD BALARA, QUEZON CITY, METRO MANILA, NCR, PHILIPPINES</p>		<p>RECOMMENDING AGENCY</p> <p>MR. ALDO REGADO MPSA DIC General Services Section</p>		<p>SUBMITTED BY</p> <p>MR. JOSE BERNABE MPSA Chief, Administrative Division</p>		<p>RECOMMENDING APPROVAL</p> <p>FRANCISCO B. GUYELA (RPL) Vice President for Administration</p>		<p>APPROVED BY</p> <p>PLUTONICA ROSARIO DE LEON Ph.D. (RPL) President, Philippine Public Safety College</p>		<p>SHEET CONTENTS</p> <p>FRONT PAGE</p>		<p>SHEET NAME</p> <p>A-01</p>		<p>SHEET NO.</p> <p>01 OF 03</p>	
<p>PROJECT TITLE</p> <p>IMPROVEMENT OF CONFERENCE ROOM ACCENT WALL AT PPSC HEAD OFFICE BUILDING</p>		<p>PROJECT LOCATION</p> <p>MWSS Compound Old Balara, Quezon City</p>		<p>SCALE</p> <p>AS SHOWN</p>		<p>DATE</p> <p>01-27-2023</p>		<p>DATE</p> <p>01-27-2023</p>		<p>DATE</p> <p>01-27-2023</p>		<p>DATE</p> <p>01-27-2023</p>		<p>DATE</p> <p>01-27-2023</p>			



1 PERSPECTIVES
A-02 SCALE NTS

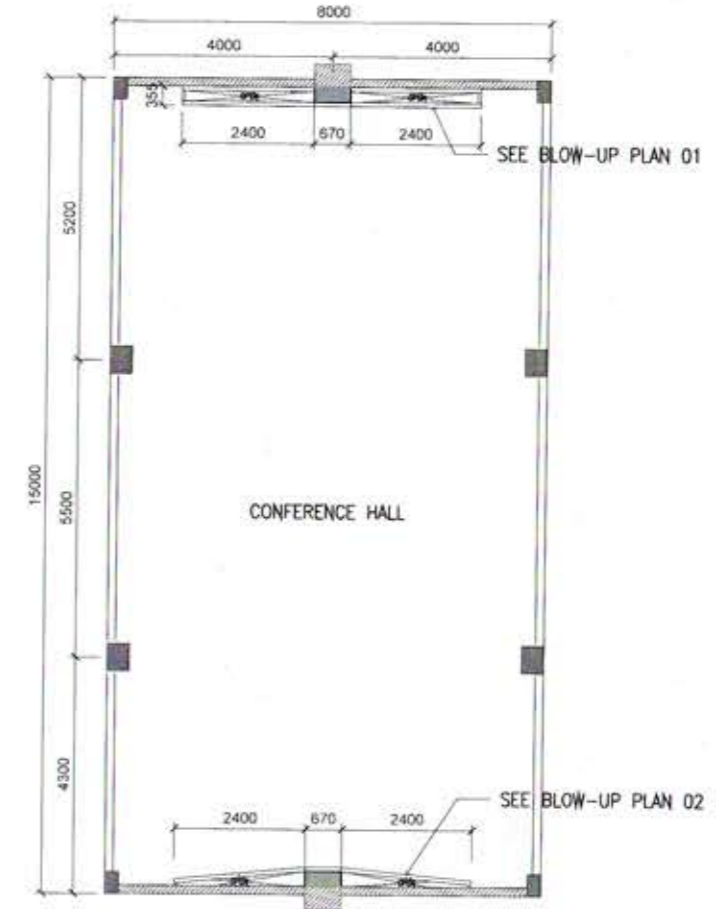

2 CONFERENCE HALL FLOOR PLAN
A-02 SCALE 1:100m

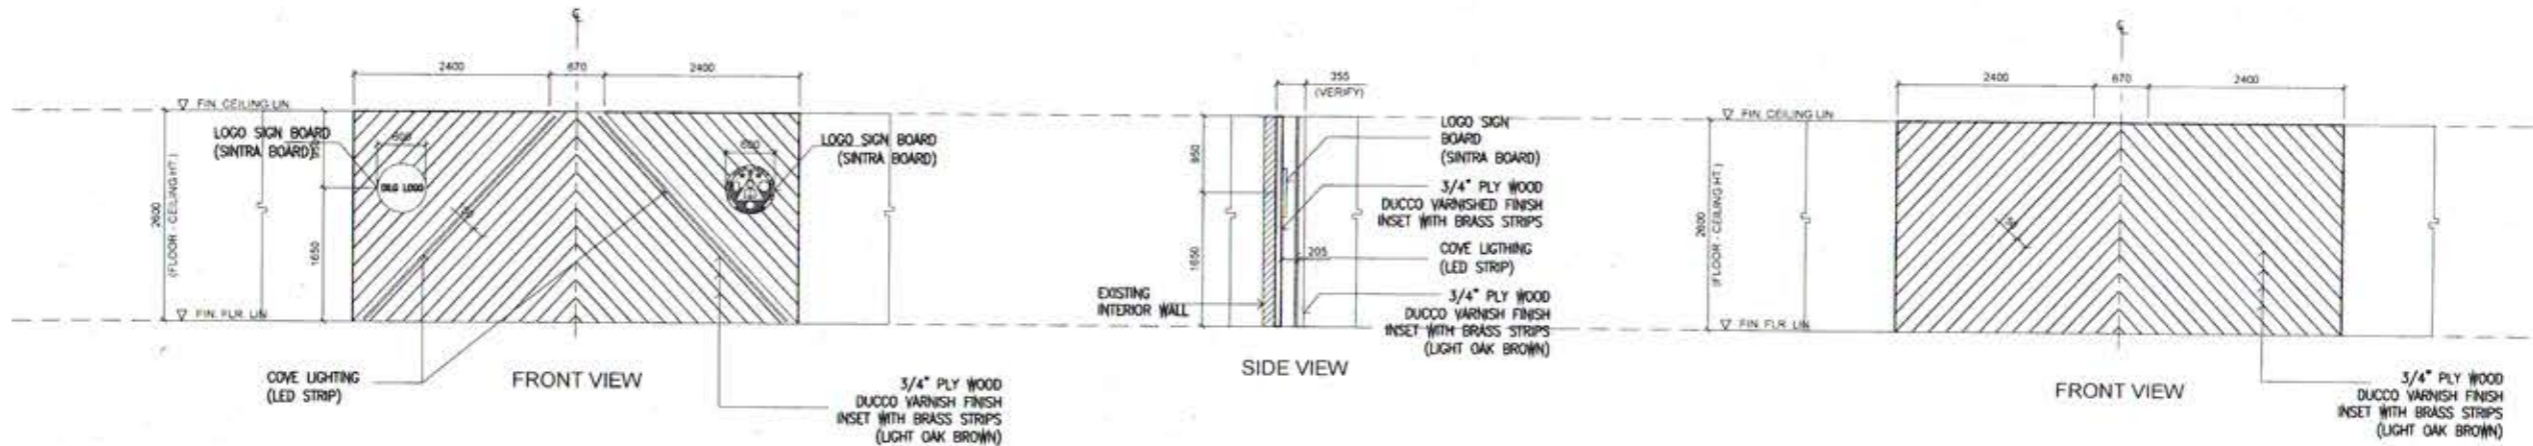

3 ELEVATION 01
A-02 SCALE 1:50m

4 ELEVATION 02
A-02 SCALE 1:50m

<p>REVISIONS</p> <table border="1"> <tr> <th>NO.</th> <th>DATE</th> <th>DESCRIPTION</th> </tr> <tr> <td>1</td> <td>11.07.2018</td> <td>ISSUED FOR PERMITTING</td> </tr> <tr> <td>2</td> <td>11.07.2018</td> <td>ISSUED FOR PERMITTING</td> </tr> </table>				NO.	DATE	DESCRIPTION	1	11.07.2018	ISSUED FOR PERMITTING	2	11.07.2018	ISSUED FOR PERMITTING	<p>PROJECT TITLE: IMPROVEMENT OF CONFERENCE ROOM ACCENT WALL AT PPSC HEAD OFFICE BUILDING</p>				<p>PROJECT CHARGE: MR. ALEX B. GAO, MPA, OIC, Services Sector</p>				<p>RECOMMENDING SUBMITTER: MR. ALEX B. GAO, MPA, OIC, Services Sector</p>				<p>SUBMITTED BY: MR. JOSE F. TORIBARTE, MPA, Chief, Administrative Division</p>				<p>RECOMMENDING APPROVER: [Signature]</p>				<p>APPROVED BY: [Signature]</p>				<p>SHEET CONTENTS: SEE ABOVE</p>				<p>SHEET NAME: A-02</p>				<p>SHEET NO: 02 OF 03</p>			
NO.	DATE	DESCRIPTION																																														
1	11.07.2018	ISSUED FOR PERMITTING																																														
2	11.07.2018	ISSUED FOR PERMITTING																																														
<p>OWNER: REPUBLIC OF THE PHILIPPINES, DEPARTMENT OF THE INTERIOR AND LOCAL GOVERNMENT, PHILIPPINE PUBLIC SAFETY COLLEGE</p> <p>ADDRESS: WISDOM CAMPUS, CORNER PULUPULAN, BRGY. 05-BALAYAN, SUEC CITY, METRO MANILA, NCR, PHILIPPINES</p>																																																